


ELECTRICAL ENGINEER: ROLANDO N. CRUZ REG. NO. 2562 DATE ISSUED: 04/19/20	PROJECT TITLE: REHABILITATION OF MULTI-PURPOSE BUILDING I IN SAN FERNANDO CAMPUS LOCATION: B/I SAN FERNANDO, CAMPS POBLACION, SAN FERNANDO, R/WAMBON	OWNER:	RECOMMENDING APPROVAL: <i>Emelia B. Ramos</i> EMELIA B. RAMOS, Ph.D CAMPUS DIRECTOR	APPROVED BY: <i>Arnulfo de Luna</i> ARNULFO DE LUNA, Ph.D SUD PRESIDENT II	DRAWN BY:	SHEET CONTENT GROUND FLOOR LIGHTING LAYOUT	SHEET E
------------------------------------------------------------------------------------------	-------------------------------------------------------------------------------------------------------------------------------------------------------------------	--------	-----------------------------------------------------------------------------------------------------	--------------------------------------------------------------------------------------------	-----------	-----------------------------------------------	-------------------


E-1

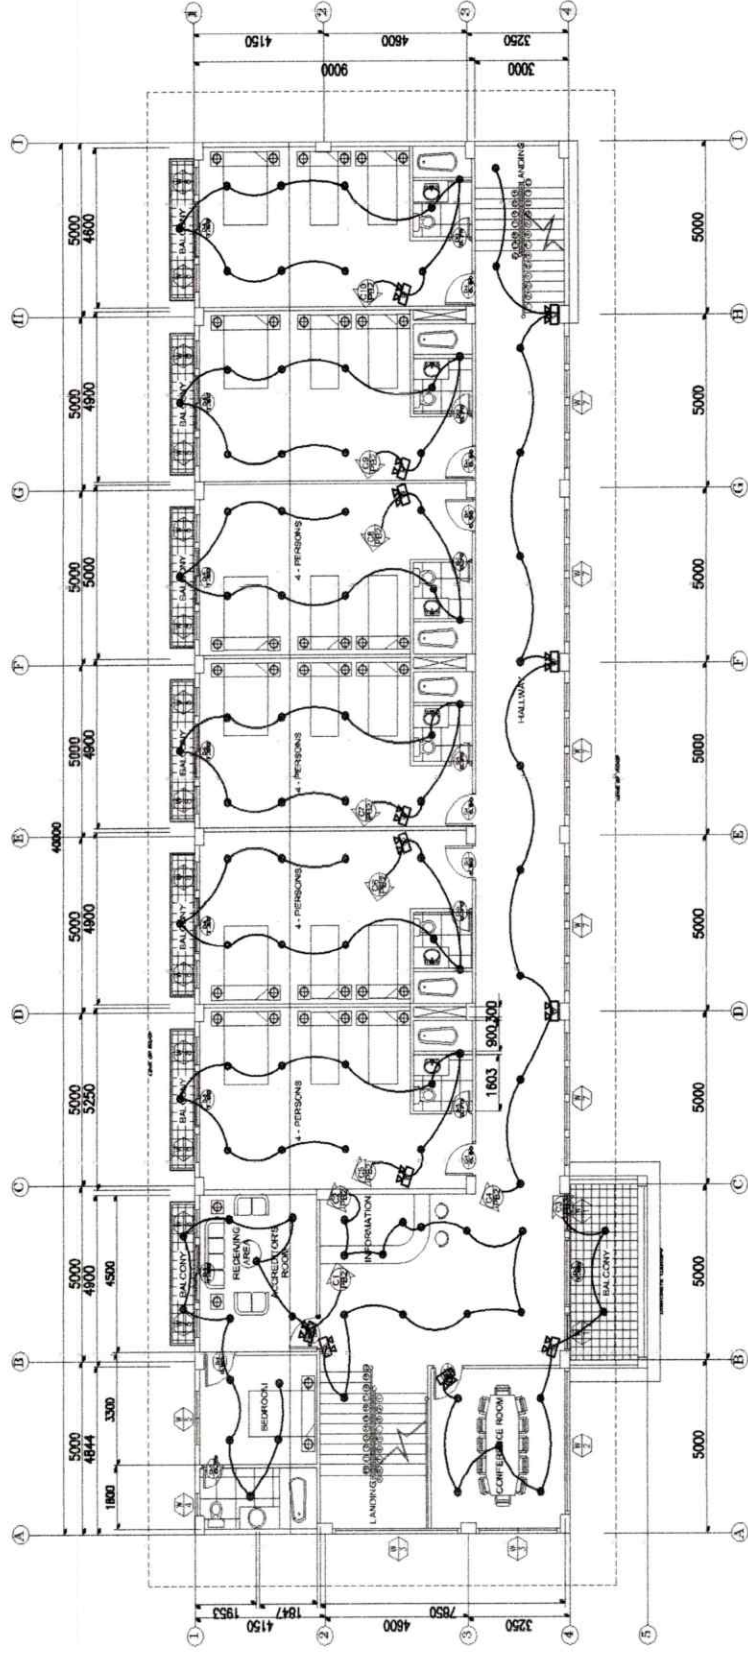

SECOND FLOOR LIGHTING LAYOUT
REVISION OF MULTI-PURPOSE BUILDING

<p>ELECTRICAL ENGINEER: ROLANDO N. CRUZ <small>PRO. NO. 2862 - 13 DEC 2012 REG. NO. 4921035 - 13 MAR 2012 DATE: 05/09/2020</small></p>	<p>PROJECT TITLE: REHABILITATION OF MULTI-PURPOSE BUILDING I IN SAN FERNANDO CAMPUS <small>LOCATION: TRU SAN FERNANDO, CAMPUS FOLACION, SAN FERNANDO, R.OWSON</small></p>	<p>OWNER: EMELIA B. RAMOS, Ph.D <small>CAMPUS DIRECTOR</small></p>	<p>RECOMMENDING APPROVAL: <i>Emelia B. Ramos</i> EMELIA B. RAMOS, Ph.D <small>CAMPUS DIRECTOR</small></p>	<p>APPROVED BY: <i>Arnulfo de Luna</i> ARNULFO DE LUNA, Ph.D <small>SUD PRESIDENT II</small></p>	<p>DRAWN BY: 33</p>	<p>SHEET CONTENT: SECOND FLOOR LIGHTING LAYOUT</p>	<p>SHEET E</p>
----------------------------------------------------------------------------------------------------------------------------------------------------------------------------------	-------------------------------------------------------------------------------------------------------------------------------------------------------------------------------------------	------------------------------------------------------------------------------------	-------------------------------------------------------------------------------------------------------------------------------	----------------------------------------------------------------------------------------------------------------------	--------------------------------	--------------------------------------------------------	---------------------------


E-2

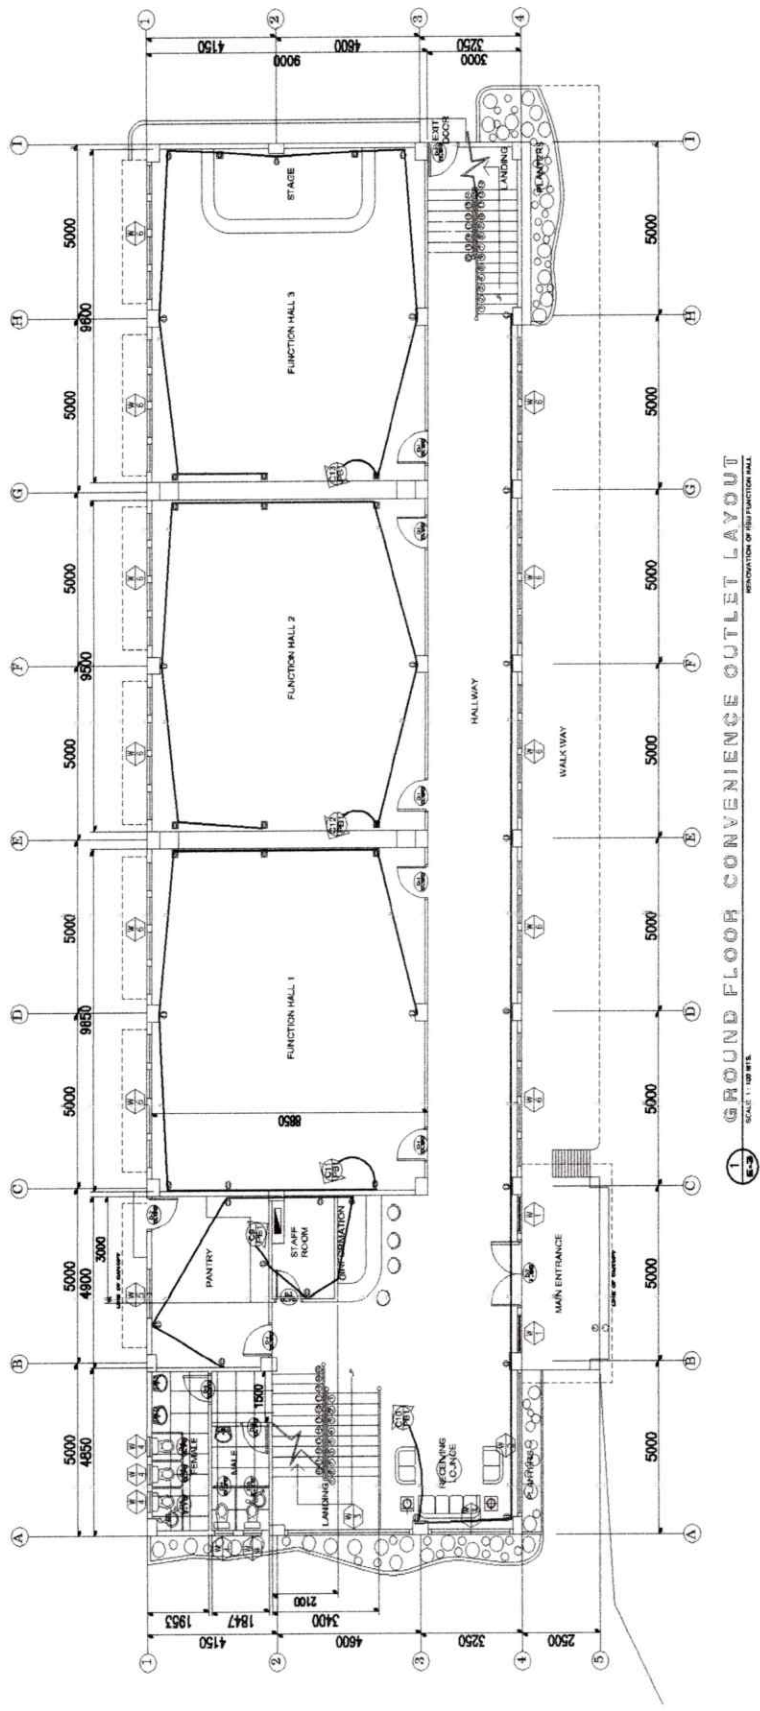

GROUND FLOOR CONVENIENCE OUTLET LAYOUT
 REHABILITATION OF BLDG FUNCTION HALL
 SCALE: 1" = 10' N.T.S.

ELECTRICAL ENGINEER: ROLANDO N. CRUZ PRC No. 2862 VAD UNIT: 9/22/2020 PRJ. NO. 49210351TH AY PMA: 02-CAN-F-11 DATE: 05/29/1992	PROJECT TITLE: REHABILITATION OF MULTI-PURPOSE BUILDING 11 IN SAN FERNANDO CAMPUS LOCATION: BLDG SAN FERNANDO, CAMPUS POBLACION, SAN FERNANDO, BOMBON	OWNER: 	RECOMMENDING APPROVAL: <i>Emelia B. Ramos</i> EMELIA B. RAMOS, Ph.D CAMPUS DIRECTOR	APPROVED BY: <i>Arnulfo de Luna</i> ARNULFO DE LUNA, Ph.D SUC PRESIDENT II	DRAWN BY: 	SHEET CONTENT: GROUND FLOOR CONVENIENCE OUTLET LAYOUT	SHEET: 34
------------------------------------------------------------------------------------------------------------------------------------------------------	--------------------------------------------------------------------------------------------------------------------------------------------------------------------	----------------	-----------------------------------------------------------------------------------------------------	--------------------------------------------------------------------------------------------	-------------------	----------------------------------------------------------	---------------------

E-3

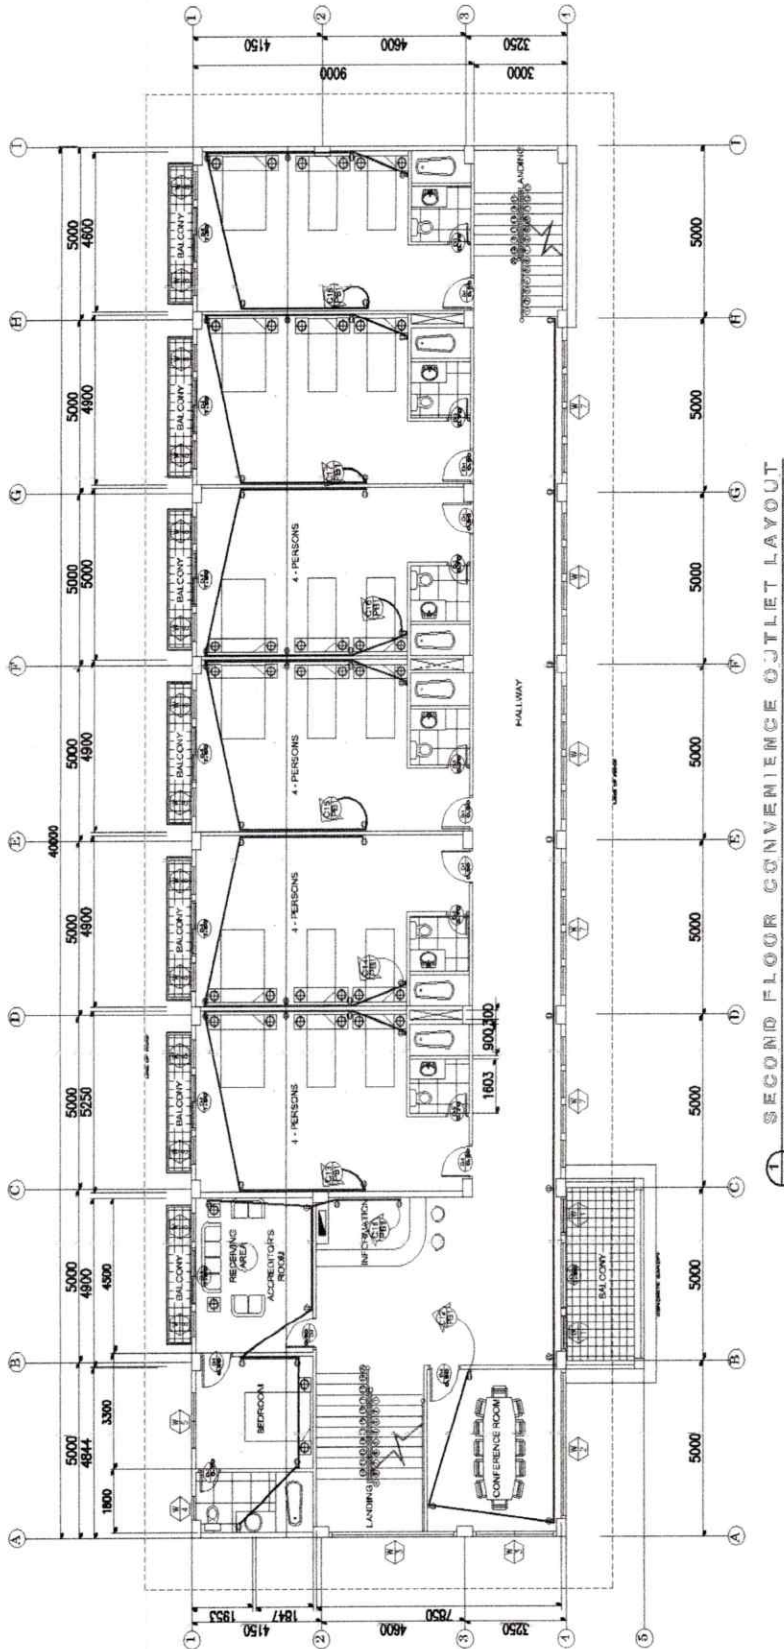

SECOND FLOOR CONVENIENCE OUTLET LAYOUT
SCALE: 1/8" = 1'-0"

ELECTRICAL ENGINEER ROLANDO N. CRUZ PRC NO. 2562 PRR NO. 49210355TH AY. PASE. COCANELL DATE: 05/18/1992	PROJECT TITLE: REHABILITATION OF MULTI-PURPOSE BUILDING I IN SAN FERNANDO CAMPUS LOCATION: BRJ SAN FERNANDO, CAMPUS POBLACION SAN FERNANDO, MARULAN	OWNER: 	RECOMMENDING APPROVAL: <i>Emelia B. Ramos</i> EMELIA B. RAMOS, Ph.D CAMPUS DIRECTOR	APPROVED BY: <i>Arnulfo de Luna</i> ARNULFO DE LUNA, Ph.D SUG. PRESIDENT II	DRAWN BY: 	SHEET CONTENT: SECOND FLOOR CONVENIENCE OUTLET LAYOUT	SHEET 1
----------------------------------------------------------------------------------------------------------------------------	------------------------------------------------------------------------------------------------------------------------------------------------------------------	----------------	-----------------------------------------------------------------------------------------------------	---------------------------------------------------------------------------------------------	-------------------	----------------------------------------------------------	-------------------

B-4