
 


1 GROUND FLOOR LIGHTING PLAN
 E-1 E-1 SCALE
 1:200

REGISTERED ELECTRICAL ENGINEER ROSLAND M. ERNIZ PROFESSIONAL ENGINEER # 28592 ADDRESS 210 ALBERTA ST. DN. PHONE # 807-527-0170 FAX # 807-527-0170 TEL:	PROJECT TITLE: Construction of Student Dormitory for the College of Agriculture, Fishery & Forestry	PREPARED BY: CAD PRATAPOR Name of Job: Novelty Hotel JOB No.: DATE: DEC. 2018
OFFICE OF SURVEY, PLANT SERVICES AND POLLUTION CONTROL UNIT ROSELAND STATE UNIVERSITY	SHEET NO. AS SHOWN	LOCATION: ROSELAND STATE UNIVERSITY - (66A) ANSTAD, NORDLJUN

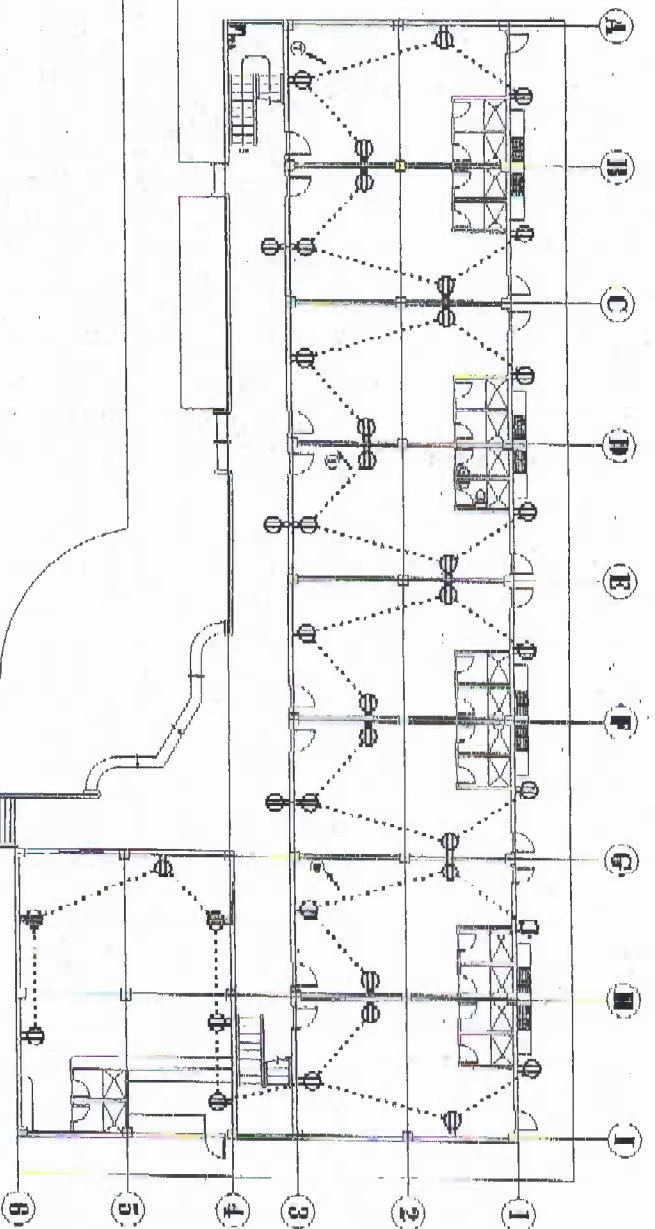





1 GROUND FLOOR C.O. LAYOUT PLAN
 SCALE 1:200

REGISTERED BY: HUNTSVILLE STATE UNIVERSITY OFFICE OF ADJUNCT, PLANNING SERVICES AND POLLUTION CONTROL UNIT		REGISTERED ENGINEER: ROLAND W. ERUZ PROFESSIONAL ELECTRICAL ENGINEER # 21572 2000 W. HUNTSVILLE AVENUE HUNTSVILLE, ALABAMA 35894 TEL: 256-833-4111 FAX: 256-833-4111		DESIGNER: LISA ANN ERSON ARCHITECTURAL ASSOCIATE ASSOCIATES OF ALABAMA 1000 W. HUNTSVILLE AVENUE HUNTSVILLE, ALABAMA 35894 TEL: 256-833-4111 FAX: 256-833-4111		PROJECT TITLE: Construction of Student Dormitory for the College of Agriculture, Forestry & Forestry LOCATION: HUNTSVILLE STATE UNIVERSITY - 3001 W. 10th Ave., Huntsville		SHEET NO.: E-2	
SHEET NUMBER: 35 SHOWN		SHEET OPERATOR: BRENDAN BROWN		JOB NO.:		DATE: DEC. 2015			

E-2

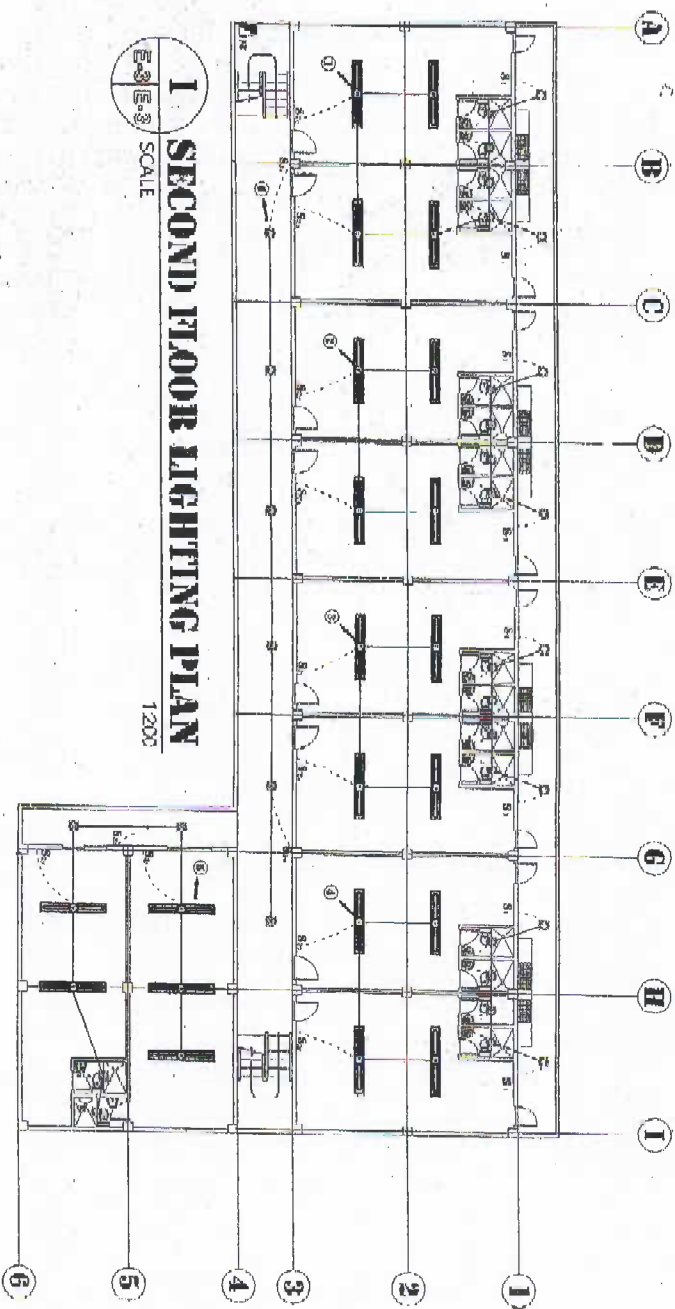

PREPARED BY: HOMERSON STATE UNIVERSITY OFFICE OF FACILITY PLANNING SERVICES AND POSITIONING CONTROL UNIT	DESIGNED BY: PHILIPPO N. ERUZ PROFESSIONAL ENGINEER # 2582 400025 2ND AVENUE, SUITE 100 MEMPHIS, TN 38117 TEL: (901) 527-1111 FAX: (901) 527-1111	CHECKED BY: JASON PATTON ARCHITECT OF RECORD ARCHITECTS OF THE LIBRA	PROJECT TITLE: Construction of Student Dormitory for the College of Agriculture, Fishery & Forestry LOCATION: HOMERSON STATE UNIVERSITY - East Campus, Rowdon	DRAWN BY: A.E. SHOWN	PREPARED BY: CAD PREPARED: Yanyan Li ICF NO.: DATE: DEC. 2018
--------------------------------------------------------------------------------------------------------------------------	----------------------------------------------------------------------------------------------------------------------------------------------------------------------------	--------------------------------------------------------------------------------------	---------------------------------------------------------------------------------------------------------------------------------------------------------------------------	--------------------------------	----------------------------------------------------------------------------------

E-3