


LEGEND:

T	END-CAP
●	SPRINKLER HEAD
○	RISER TYPE
○	RISER PIPE

1
F-5 F-5
GROUND FLOOR SPRINKLING LAYOUT PLAN
SCALE 1:100

<p>PREPARED BY: ROMBION STATE UNIVERSITY</p> <p>OFFICE OF PHYSICAL PLANNING AND FACILITIES</p>	<p>MECHANICAL ENGINEER <i>Mages B. Sapat Jr.</i></p> <p>PROJ. REG. No. : Valid thru : Date : TIN : Place :</p>
<p>CHECKED BY: <i>[Signature]</i></p> <p>APPROVED BY: <i>[Signature]</i> MERLIN P. CALAYANAN JR. L.L.C.S.E. R.C.S.</p>	<p>PROJECT TITLE: REHABILITATION AND FINISHING OF OLD/EXISTING UNIVERSITY LIBRARY</p> <p>LOCATION: ROMBION STATE UNIVERSITY - Main Campus, Lingsang, Olongapo, Zamboanga</p>
<p>SHEET CONTENT: AS SHOWN</p>	<p>PREPARED BY: CAD OPERATOR: BCSC / SLM JOB NO. : DATE :</p>
<p>F-5</p>	

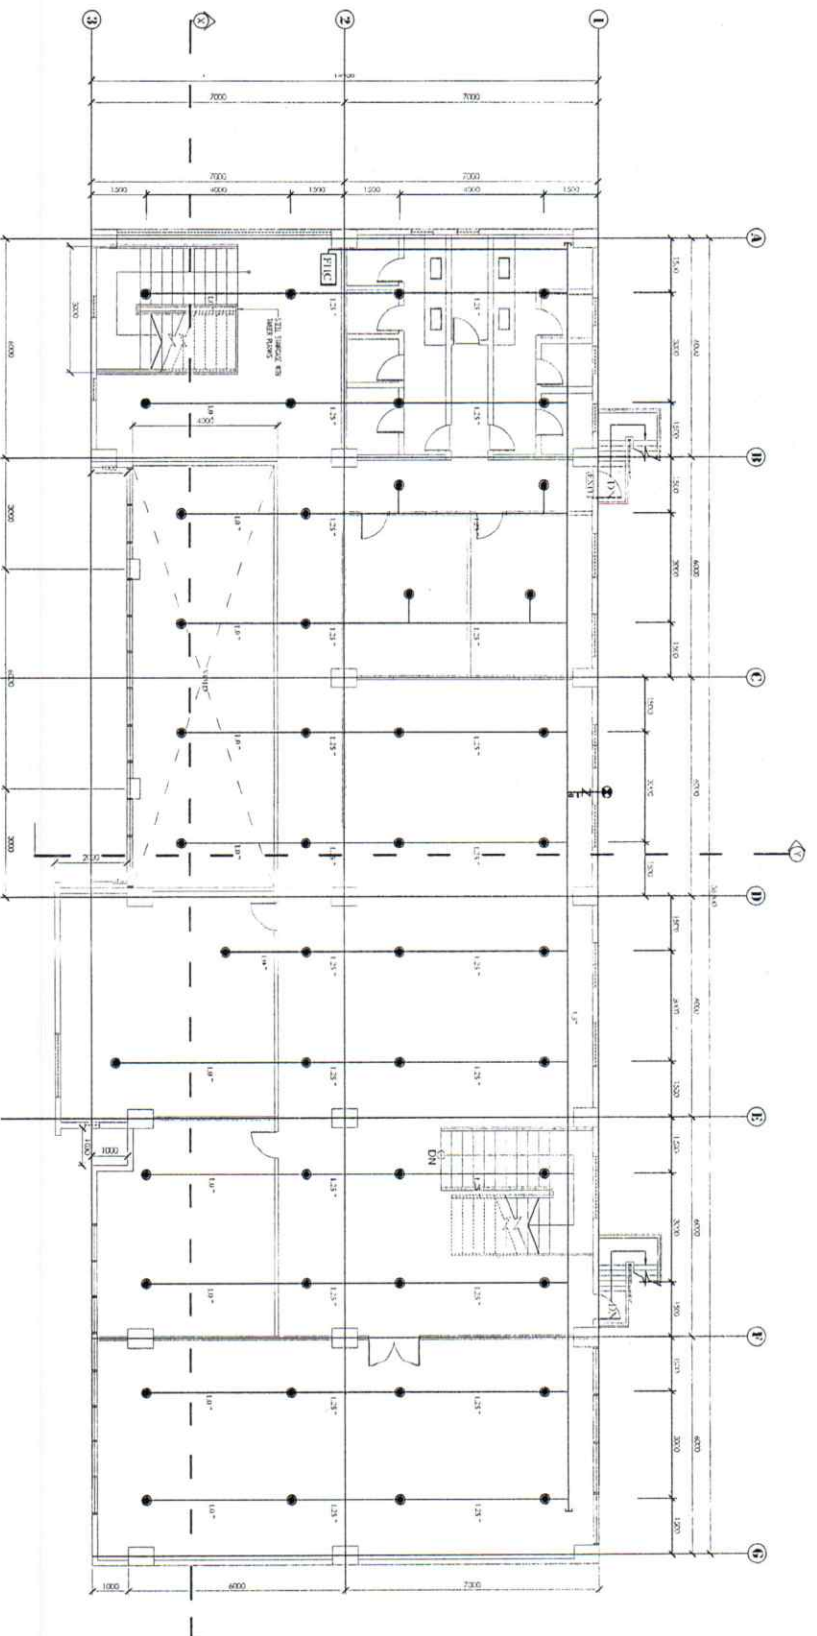


LEGEND:

- T END CAP
- SPRINKLER HEAD
- PENDENT TYPE
- ⊙ RISER PIPE

1 SECOND FLOOR SPRINKLING LAYOUT PLAN
 F-6 SCALE 1:100

PREPARED BY: ROMBION STATE UNIVERSITY OFFICE OF PHYSICAL PLANT AND FACILITIES	MECHANICAL ENGINEER <i>Michael B. Mabe</i> MBE REG. RES. NO.: Validity: License: TIN:	CHECKED BY: JASON S. SUTTON PROJECT TITLE: REHABILITATION AND FURNISHING OF OLD/EXISTING UNIVERSITY LIBRARY LOCATION: ROMBION STATE UNIVERSITY - Main Campus, Limawan, Odonggan, Romblon	ISSUED CONTENT: AS SHOWN
CAD OPERATOR: BCSC / SIM JOB NO.: DATE:		<div style="border: 1px solid black; border-radius: 50%; width: 40px; height: 40px; display: flex; align-items: center; justify-content: center; margin: 0 auto;"> F-6 </div>	

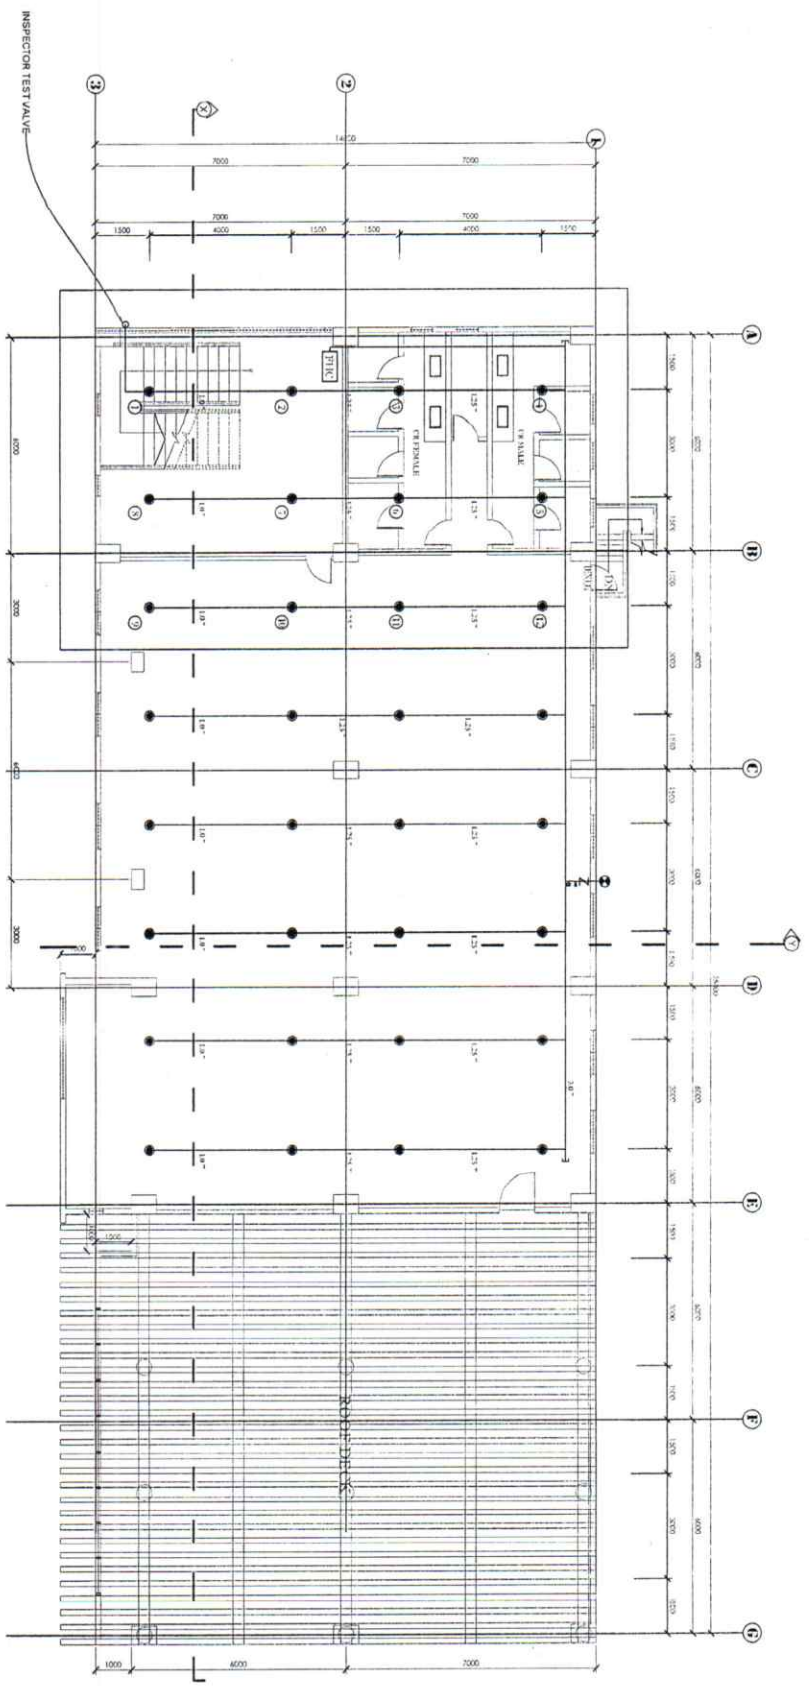

LEGEND:


- T END CAP
- SPRINKLER HEAD
- PENDENT TYPE
- RISER PIPE

1
F-7 F-7
SCALE


1 THIRD FLOOR SPRINKLING LAYOUT PLAN
1:100

PROJECT INFORMATION:	MECHANICAL ENGINEER: <i>[Signature]</i> Moses B. Moore Jr.	DESIGNED BY: <i>[Signature]</i> JASON P. REYNOLDS PROJECT MANAGER	PROJECT TITLE: REHABILITATION AND FURNISHING OF OLD/EXISTING UNIVERSITY LIBRARY	SHEET CONTENT: AS SHOWN	PREPARED BY: CAD OPERATOR: BSSC / SJM
OFFICE OF PHYSICAL PLANT AND FACILITIES	PRC REG. NO.: [Blank]	APPROVED BY: <i>[Signature]</i> MURRAY F. CANTAINI, ANTHONY D. CISE SEAL	LOCATION: ROMBLON STATE UNIVERSITY - Main Campus, Iwasag, Odonggan, Romblon	DATE:	DATE:
	PR NO.:	DATE:			
	PRC:	TIN:			

F-7

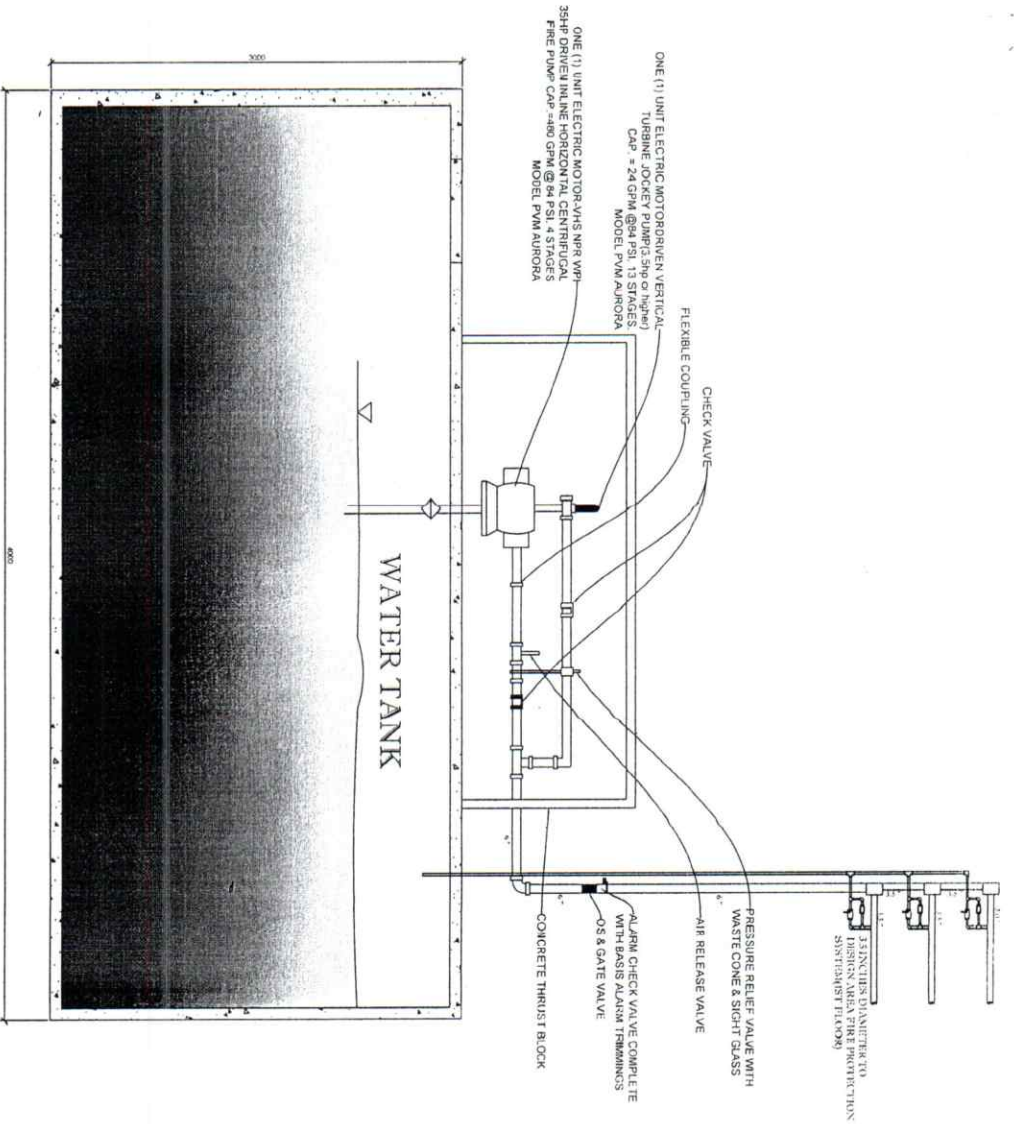


1 PUMP ROOM DETAIL AND INSTALLATION
 SCALE: F-8 F-8
 NTS

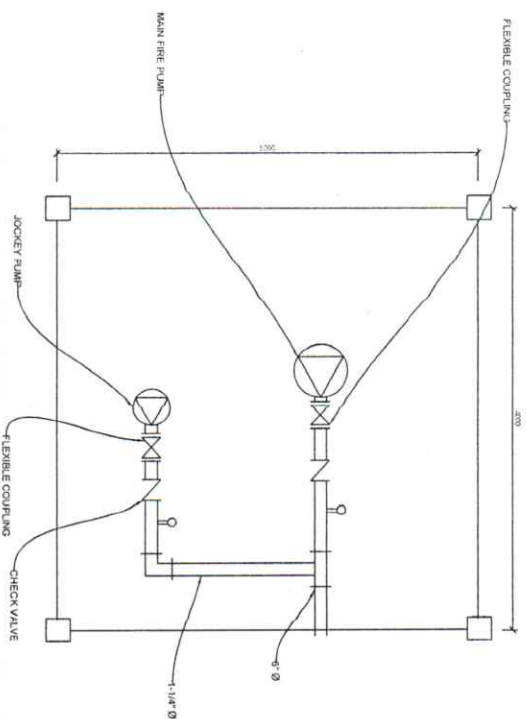

2 PUMP HOUSE ASSEMBLY
 SCALE: F-8 F-8

PREPARED BY: ROXBOROUGH STATE UNIVERSITY OFFICE OF PHYSICAL PLANT AND FACILITIES	MECHANICAL ENGINEER <i>McGee / B. Madsen</i>	CHECKED BY: JASON E. BLTON PHYSICS INSTRUCTOR	PROJECT TITLE: REHABILITATION AND FURNISHING OF OLD/EXISTING UNIVERSITY LIBRARY LOCATION: ROXBOROUGH STATE UNIVERSITY - Main Campus, Lenoir, Ohio	SHEET CONTENT: AS SHOWN	PREPARED BY: CAD OPERATOR BSCC / SIM	F-8
PRC REG. NO.: PTH NO.: Place:	Validity: URB: TIN:	APPROVED BY: MHRMANE / KAVANAY-SMITH, D. CESH RPT President	DATE:	JOB NO.:	DATE:	

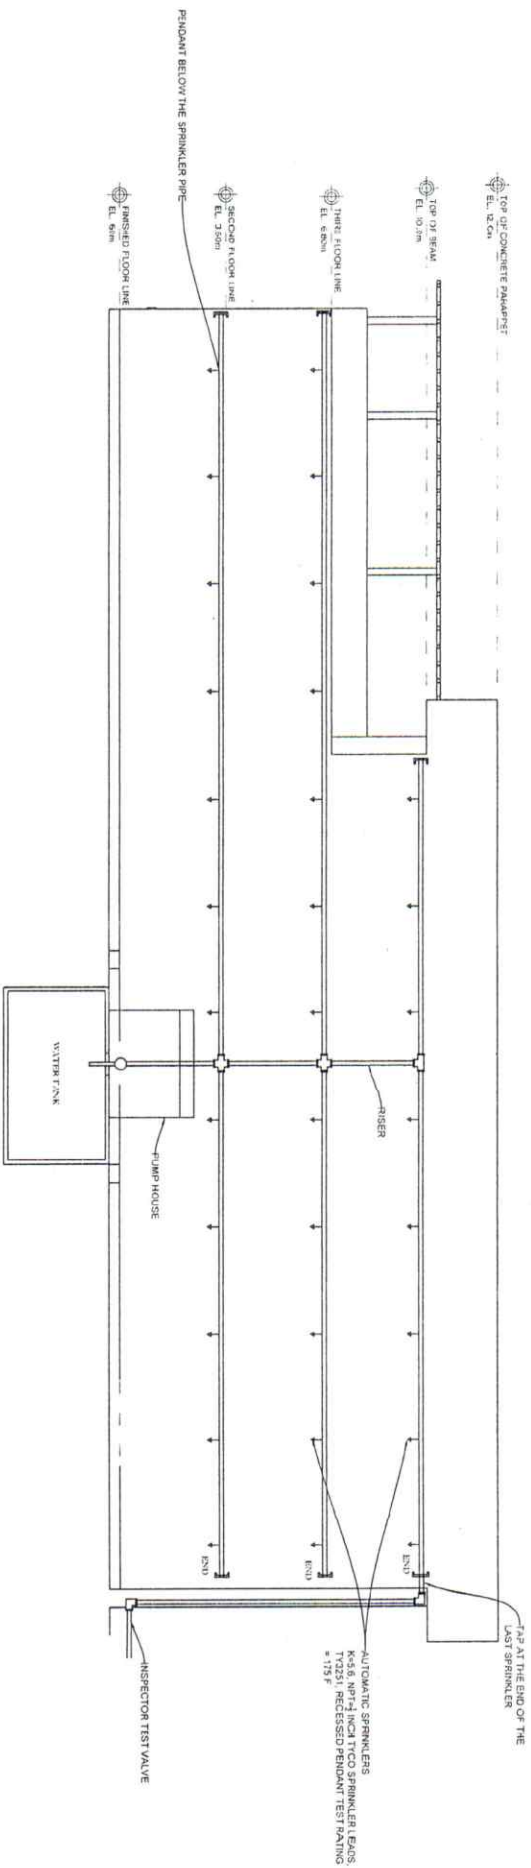


LEGEND:


□	90 DEG LONG TURN BELLOW
□	TEE
N	ROTTERDAAM VALVE
P	FLOW SWITCH
Z	ALABAMA CHECK VALVE
□	INSPECTOR TEST VALVE
□	SHOT GLASS
⊗	OS&Y VALVE
↑	RISER NIPPLE
↑	PRESSURE GAUGE
◇	STRAINER

1 PIPING LAYOUT
F-9 F-9 SCALE 1:100

PREPARED BY: Notes / B. M. BART JR ROMBLON STATE UNIVERSITY OFFICE OF PHYSICAL PLANT AND FACILITIES		CHECKED BY: JASON P. REITON PROJECT TITLE: REHABILITATION AND FURNISHING OF OLD/EXISTING UNIVERSITY LIBRARY LOCATION: ROMBLON STATE UNIVERSITY - Main Campus, Linaoan, Odongon, Romblon		SHEET CONTINUED: AS SHOWN	
REVISIONS: 1 PRC REG. NO.: 1011 PTR NO.: 1011 DATE: 10/10/11 TIN: 1011		APPROVED BY: JASON P. REITON PROJECT MANAGER: JASON P. REITON MR. JASON P. REITON, Ed.D., CRP SRP, President		PREPARED BY: BSC / SIM JOB NO.: 1011 DATE: 10/10/11	
F-9					

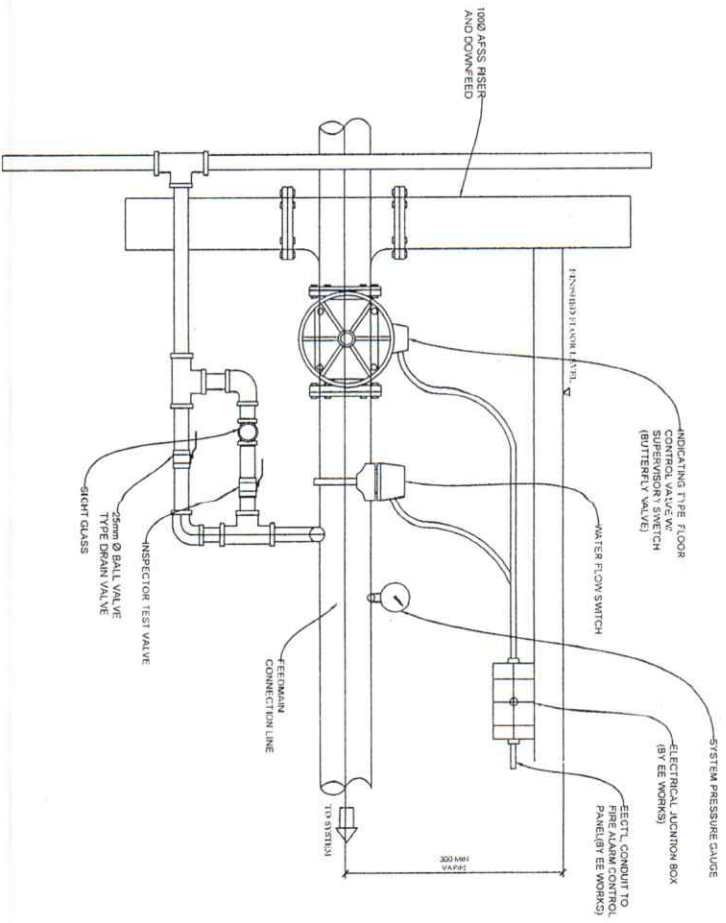

1 FLOOR CONTROL VALVE ASSEMBLY
NTS.

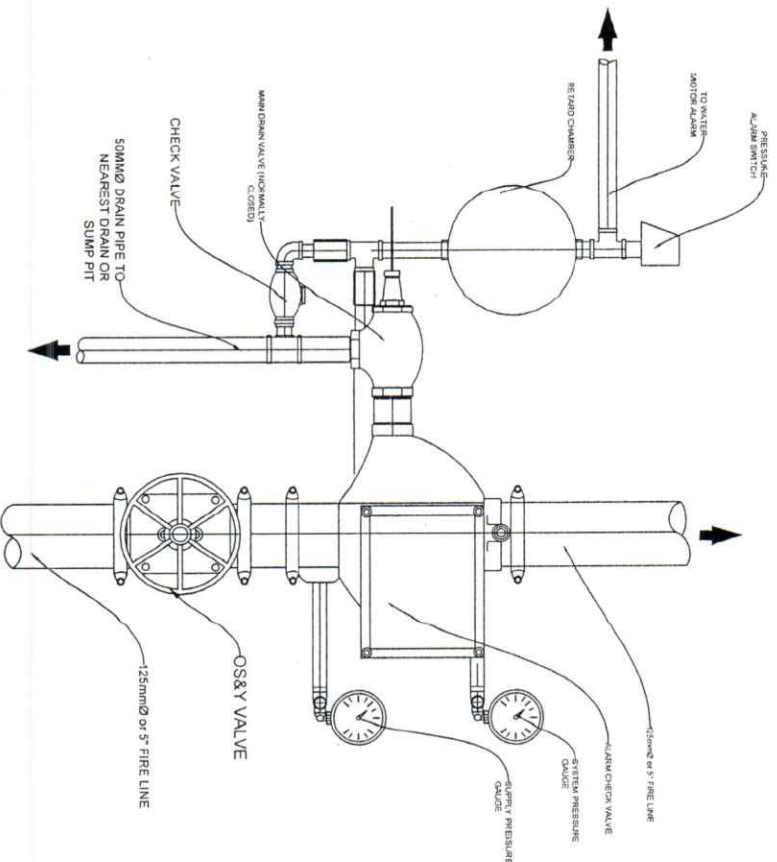

2 ALARM CHECK VALVE ASSEMBLY
NTS.

PREPARED BY: William ROMBLON STATE UNIVERSITY OFFICE OF PHYSICAL PLANT AND FACILITIES		MECHANICAL ENGINEER: William Mages R. MABARJE		CHECKED BY: Anton T. RAYON ANTON T. RAYON		PROJECT TITLE: REHABILITATION AND FURNISHING OF OLD/EXISTING UNIVERSITY LIBRARY		SHEET CONTENT: AS SHOWN		PREPARED BY: BCSC / SJM		F-10
P.R. NO.: Date:		VARIETY: Date:		APPROVED BY: HERNAN P. ANDALAMAN HERNAN P. ANDALAMAN		LOCATION: ROMBLON STATE UNIVERSITY - Main Campus, Avenida Olingatan, Romblon		CAD OPERATOR: BCSC / SJM		JOB NO.:		
P.R. NO.: Date:		VARIETY: Date:		APPROVED BY: HERNAN P. ANDALAMAN HERNAN P. ANDALAMAN		LOCATION: ROMBLON STATE UNIVERSITY - Main Campus, Avenida Olingatan, Romblon		CAD OPERATOR: BCSC / SJM		JOB NO.:		