

ELECTRICAL

**1** **GROUND FLOOR LIGHTING LAYOUT PLAN**  
 SCALE 1:100

PREPARED BY: [Signature] ELECTRICAL ENGINEER PROJECT TITLE: REHABILITATION AND FURNISHING OF OLD/EXISTING UNIVERSITY BUILDING SHEET CONTENT: AS SHOWN PREPARED BY: CAD OPERATOR

ROMBLON STATE UNIVERSITY

**ROLANDON CRUZ**

ASAPUL RAYON

OFFICE OF PHYSICAL PLANT AND FACILITIES

PROCESSED BY: [Signature] ENGINEER # 2602

APPROVED BY:

**REHABILITATION AND FURNISHING OF OLD/EXISTING UNIVERSITY BUILDING**

AS SHOWN

PREPARED BY:

CAD OPERATOR

BCSC / SIM

JOB NO.:


DATE:

**E-1**

PROCESSED BY: [Signature] ENGINEER # 2602  
 DATE: 1/22/21  
 OFFICE OF PHYSICAL PLANT AND FACILITIES  
 ROMBLON STATE UNIVERSITY  
 4801939

APPROVED BY: [Signature]  
 MR. RAYON RAYON  
 ASAPUL RAYON  
 ASAPUL RAYON

PROJECT TITLE: REHABILITATION AND FURNISHING OF OLD/EXISTING UNIVERSITY BUILDING  
 LOCATION: ROMBLON STATE UNIVERSITY - Main Campus, Iwang, Odingan, Romblon

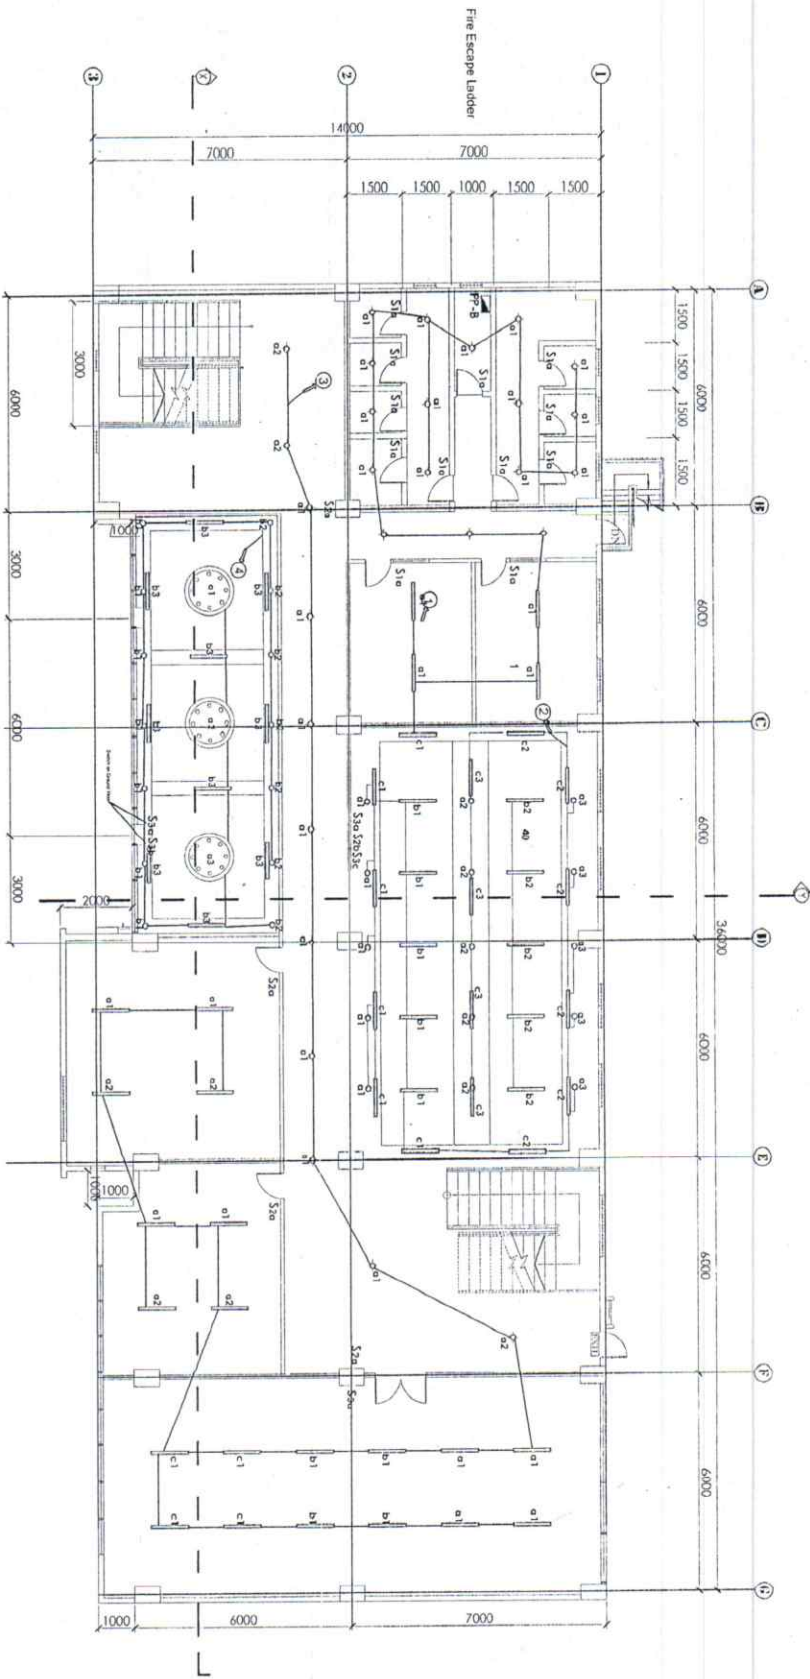

**1 SECOND FLOOR LIGHTING LAYOUT PLAN**  
**E-2-E-2 SCALE**  
 1:100

PREPARED BY: **ROLANSON CRUZ** ELECTRICAL ENGINEER CHECKED BY: **INOSENCIO REYES** ELECTRICAL ENGINEER

PROJECT TITLE: **REHABILITATION AND FURNISHING OF OLD/EXISTING UNIVERSITY LIBRARY**

OFFICE OF PHYSICAL PLANT AND FACILITIES  
 ROMBLON STATE UNIVERSITY  
 ADDRESS: **ROMBLON STATE UNIVERSITY - Main Campus, Ivaog, Davao Region**


PROJ. NO.: **0324023** DATE: **1/4/21**

SHEET CONTINUED: **AS SHOWN**

PREPARED BY: **CAD OPERATOR: BSC / SIM**


DATE: **JOB NO.:**



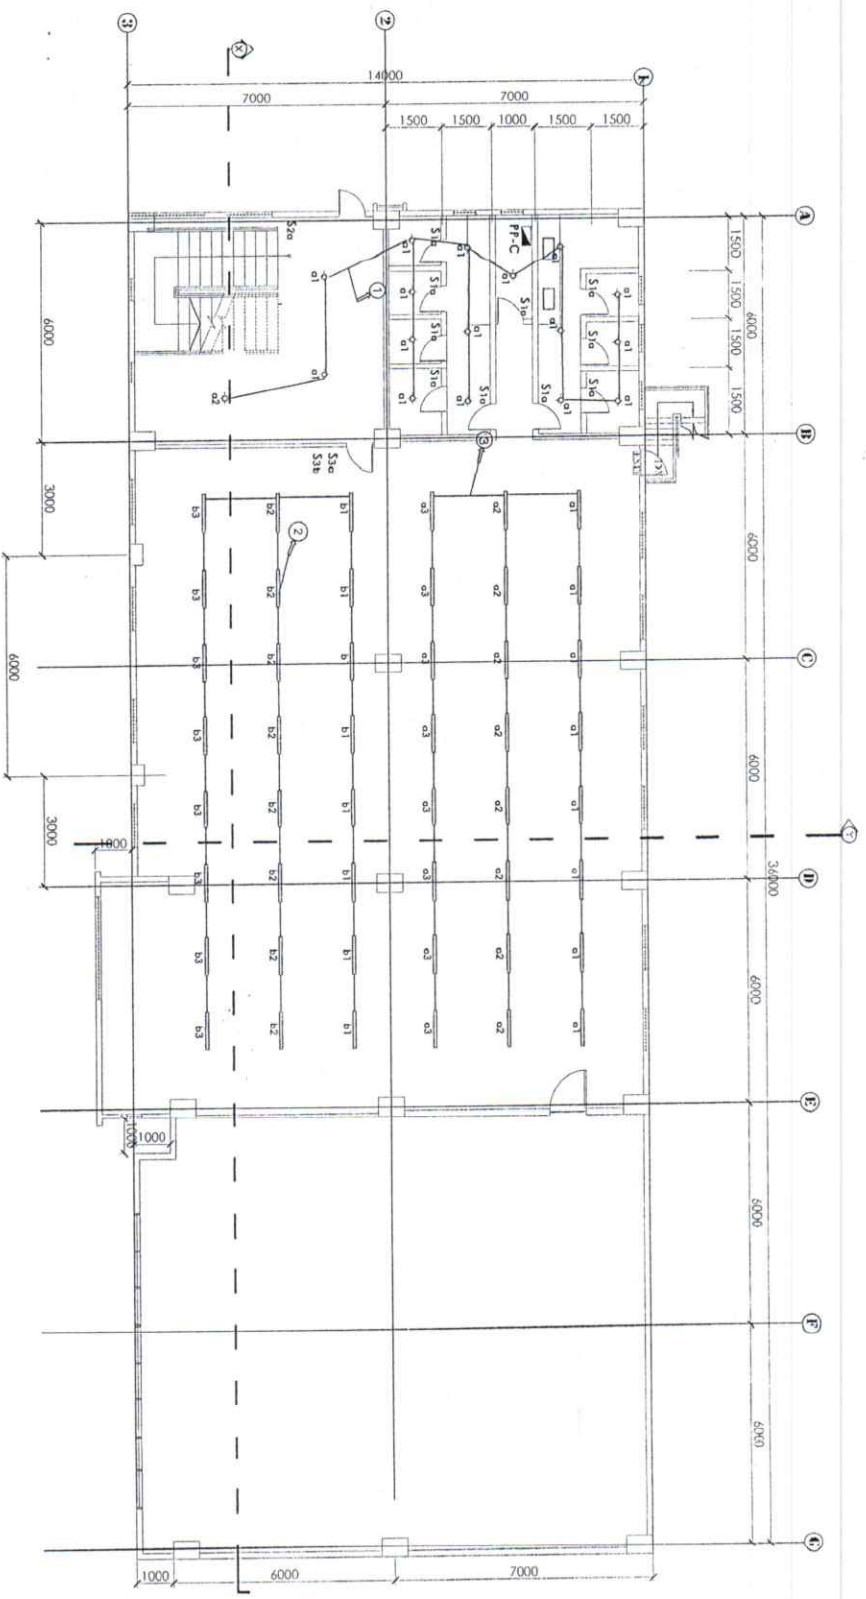

E-3
E-3
**I THIRD FLOOR LIGHTING LAYOUT PLAN**  
 SCALE 1:100

PREPARED BY: <b>ROMBLON STATE UNIVERSITY</b> OFFICE OF PHYSICAL PLANT AND FACILITIES	ELECTRICAL ENGINEER <b>ROLANDO N. CRUZ</b> PROFESSIONAL ELECTRICAL ENGINEER # 2488 AFFIDAVIT BY: DATE: 1991 FEB 14 ADDRESS: 1429	CHECKED BY: <b>LEONOR F. RONDON</b> PROJECT TITLE: <b>REHABILITATION AND FURNISHING OF          OLD/EXISTING UNIVERSITY BUILDING</b> LOCATION: ROMBLON STATE UNIVERSITY - Main Campus, Linares, General, Romblon	SHEET CONTENT: AS SHOWN	PREPARED BY: CAD OPERATOR: BCSC / SM JOB NO.: DATE:
<span style="border: 1px solid black; border-radius: 50%; padding: 10px; font-size: 24px; font-weight: bold;">E-3</span>				

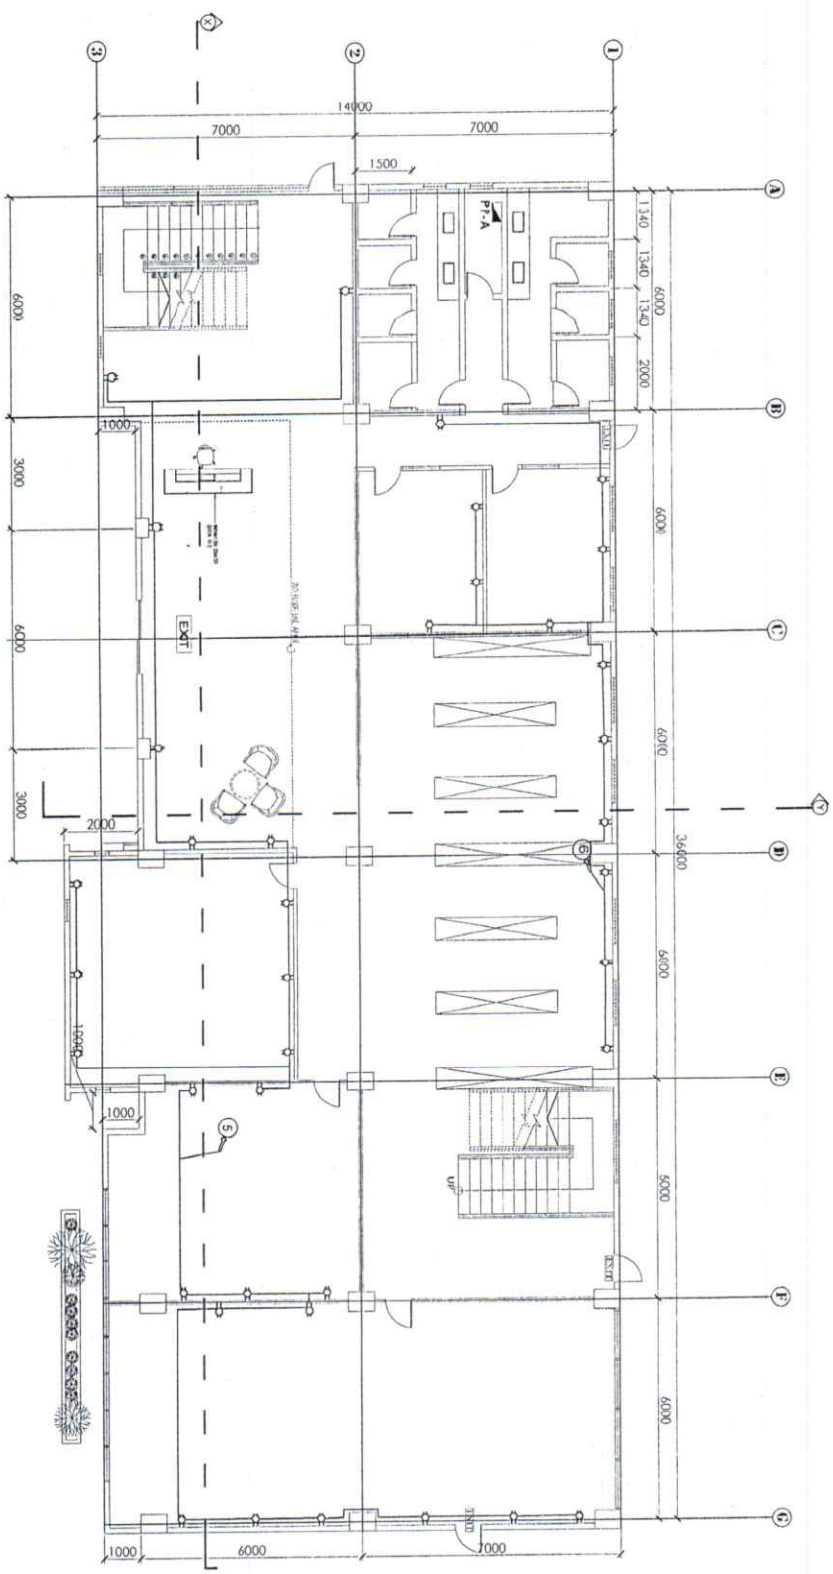

E-4
E-4
**1 GROUND FLOOR OUTLET LAYOUT PLAN**  
 SCALE 1:100

PREPARED BY: \_\_\_\_\_  
 ELECTRICAL ENGINEER  
 CHECKED BY: \_\_\_\_\_  
 PROJECT TITLE:

ROMBION STATE UNIVERSITY

**ROLANDO N. CRUZ**

PRC REG. NO. 10211, Electrical Engineering, ECE # 266  
 PRC REG. NO. 10211, Electrical Engineering, ECE # 266  
 PRC REG. NO. 10211, Electrical Engineering, ECE # 266

OFFICE OF PHYSICAL PLANT AND FACILITIES

SHEET CONTENT:  
AS SHOWN

PREPARED BY:  
CAD OPERATOR:


BCSC / SLM

JOB NO.:

DATE:

LOCATION: ROMBION STATE UNIVERSITY - Main Campus, Learning, Olongapo, Bantalan

E-4

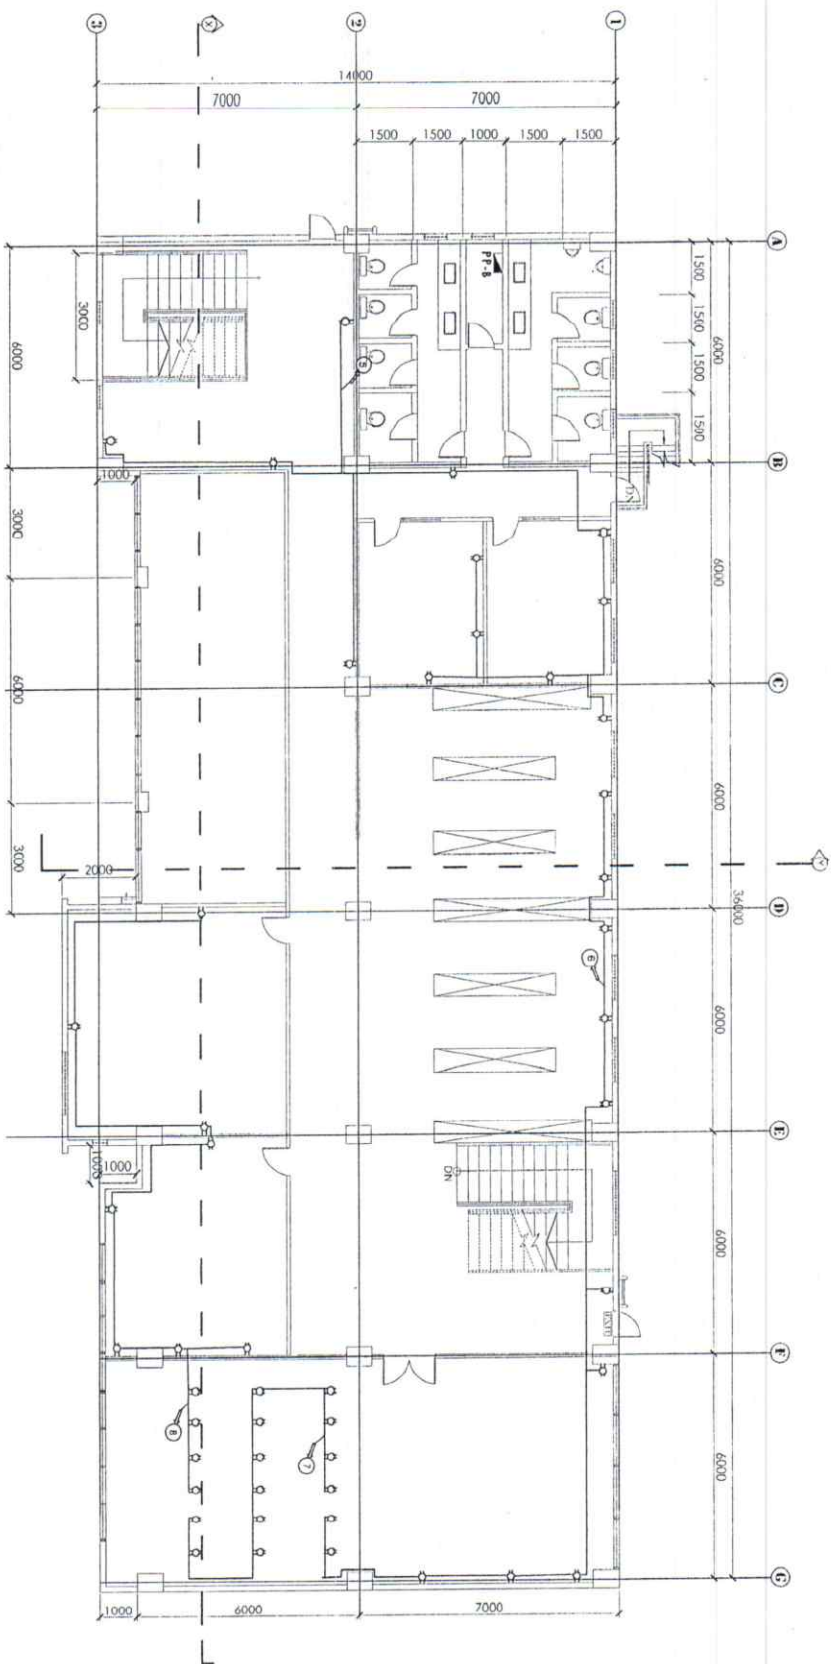

E-S-E-5

# 1 SECOND FLOOR UTILITY LAYOUT PLAN

1:100

PREPARED BY :

**ROMBION STATE UNIVERSITY**

**OFFICE OF PHYSICAL PLANT AND FACILITIES**

ELECTRICAL ENGINEER

**ROLYANNO I. CRUZ**

CHECKED BY :

JASON F. REBON

PROJECT TITLE :

**REHABILITATION AND FURNISHING OF  
OLD/EXISTING UNIVERSITY BUILDING**

SHEET CONTENT :

**AS SHOWN**

PREPARED BY :

**CAD OPERATOR**

DESIGNED BY :

**BSCE / SLIM**

JOB NO. :


DATE :

DATE :



PRC REG NO. : 2017-0001  
PRJ NO. : 2017-0001  
DATE : 11/12/17  
NO. : 1/12

LOCATION : ROMBION STATE UNIVERSITY - Main Campus, Jarang, Gibson, Rombion

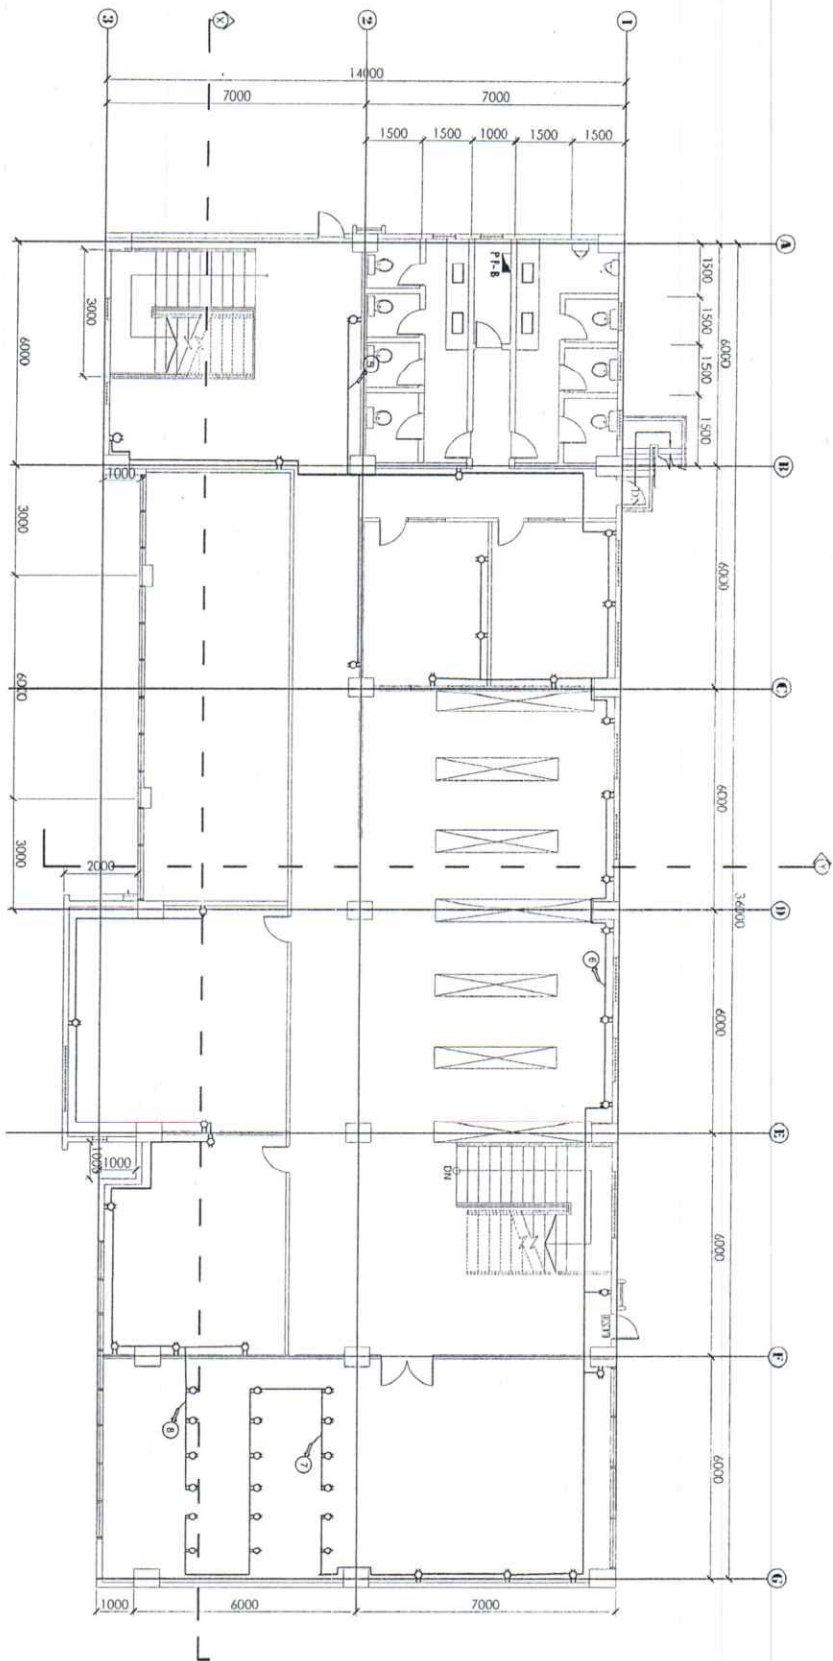

**1 SECOND FLOOR OUTLET LAYOUT PLAN**  
**E-5-E-5** SCALE  
 1:100

PREPARED BY: ELECTRICAL ENGINEER

**ROMBLON STATE UNIVERSITY**

OFFICE OF PHYSICAL PLANT AND FACILITIES

**ROLANDINO CRUZ**

PROJ. REG. NO. 14581  
 REG. DATE: 03/21/98  
 REG. EXPIRES: 03/21/03

DESIGNED BY: **JASON F. BRISON**

ARCHITECT

DATE: 1/4/12

PROJECT TITLE:

**REHABILITATION AND FURNISHING OF OLD/EXISTING UNIVERSITY BUILDING**

SHEET CONTAINS:

AS SHOWN

PREPARED BY:

CAD OPERATOR:

BCSC / SLM


JOB NO.:

DATE:

**E-5**

PROJ. NO. 14581  
 DATE: 1/4/12  
 PREPARED BY: JASON F. BRISON  
 ARCHITECT

LOCATION: ROMBLON STATE UNIVERSITY - Main Campus, Iwasan, Cudugan, Romblon

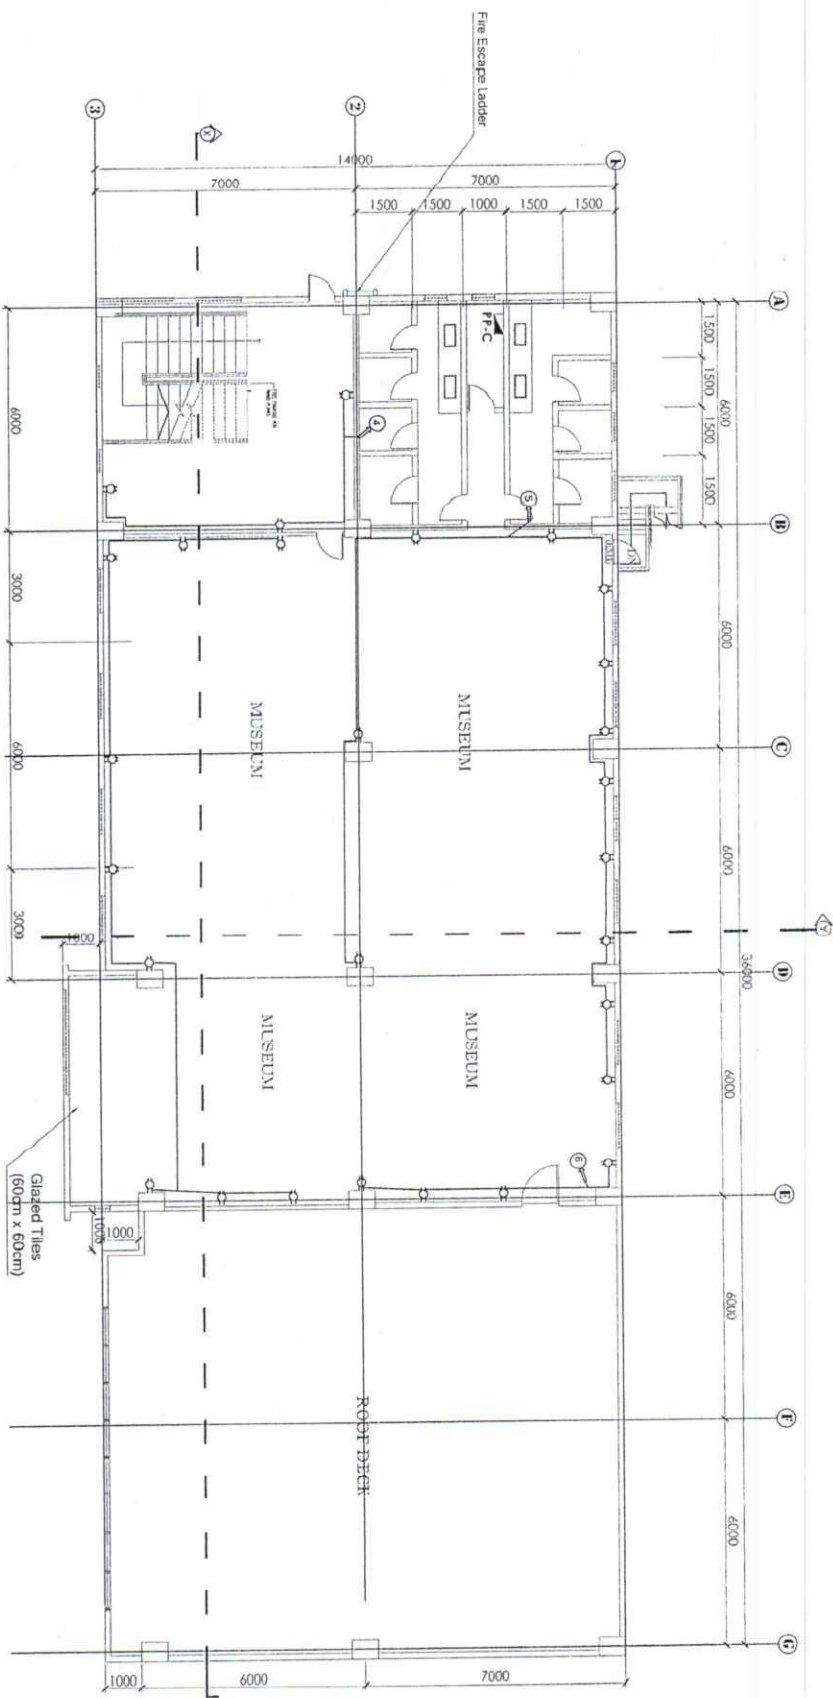

# I THIRD FLOOR OUTLET LAYOUT PLAN

E-6-E-6 SCALE 1:100

PREPARED BY: <b>KOMBION STATE UNIVERSITY</b>	ELECTRICAL ENGINEER <b>ROLAND O. CRUZ</b> <small>PROFESSOR OF ELECTRICAL ENGINEERING          COLLEGE OF ENGINEERING          KOMBION STATE UNIVERSITY</small>	CHECKED BY: <small>PROFESSOR</small> <b>WENJIAN CATALAN/MANITTE D. CRIS</b> <small>RES. PROFESSOR</small>	PROJECT TITLE: <b>REHABILITATION AND FINISHING OF          OLD/EXISTING UNIVERSITY BUILDING</b>
OFFICE OF PHYSICAL PLANT AND FACILITIES <small>PHYSICAL PLANT AND FACILITIES DIVISION          OFFICE OF PHYSICAL PLANT AND FACILITIES          KOMBION STATE UNIVERSITY</small>	LOCATION: <b>KOMBION STATE UNIVERSITY - Main Campus, Linaang, Mamburao, Bantayan</b>	SHEET CONTENT: <b>AS SHOWN</b>	REVISION BY: <b>CAD OPERATOR:</b> <b>BSCC / SIM</b> JOB NO.: DATE: